


SINGLE LINE DIAGRAM OF FLOAT CHARGER & FLOAT CUM BOOST CHARGER AS PER ATTACHED TECH SPEC.

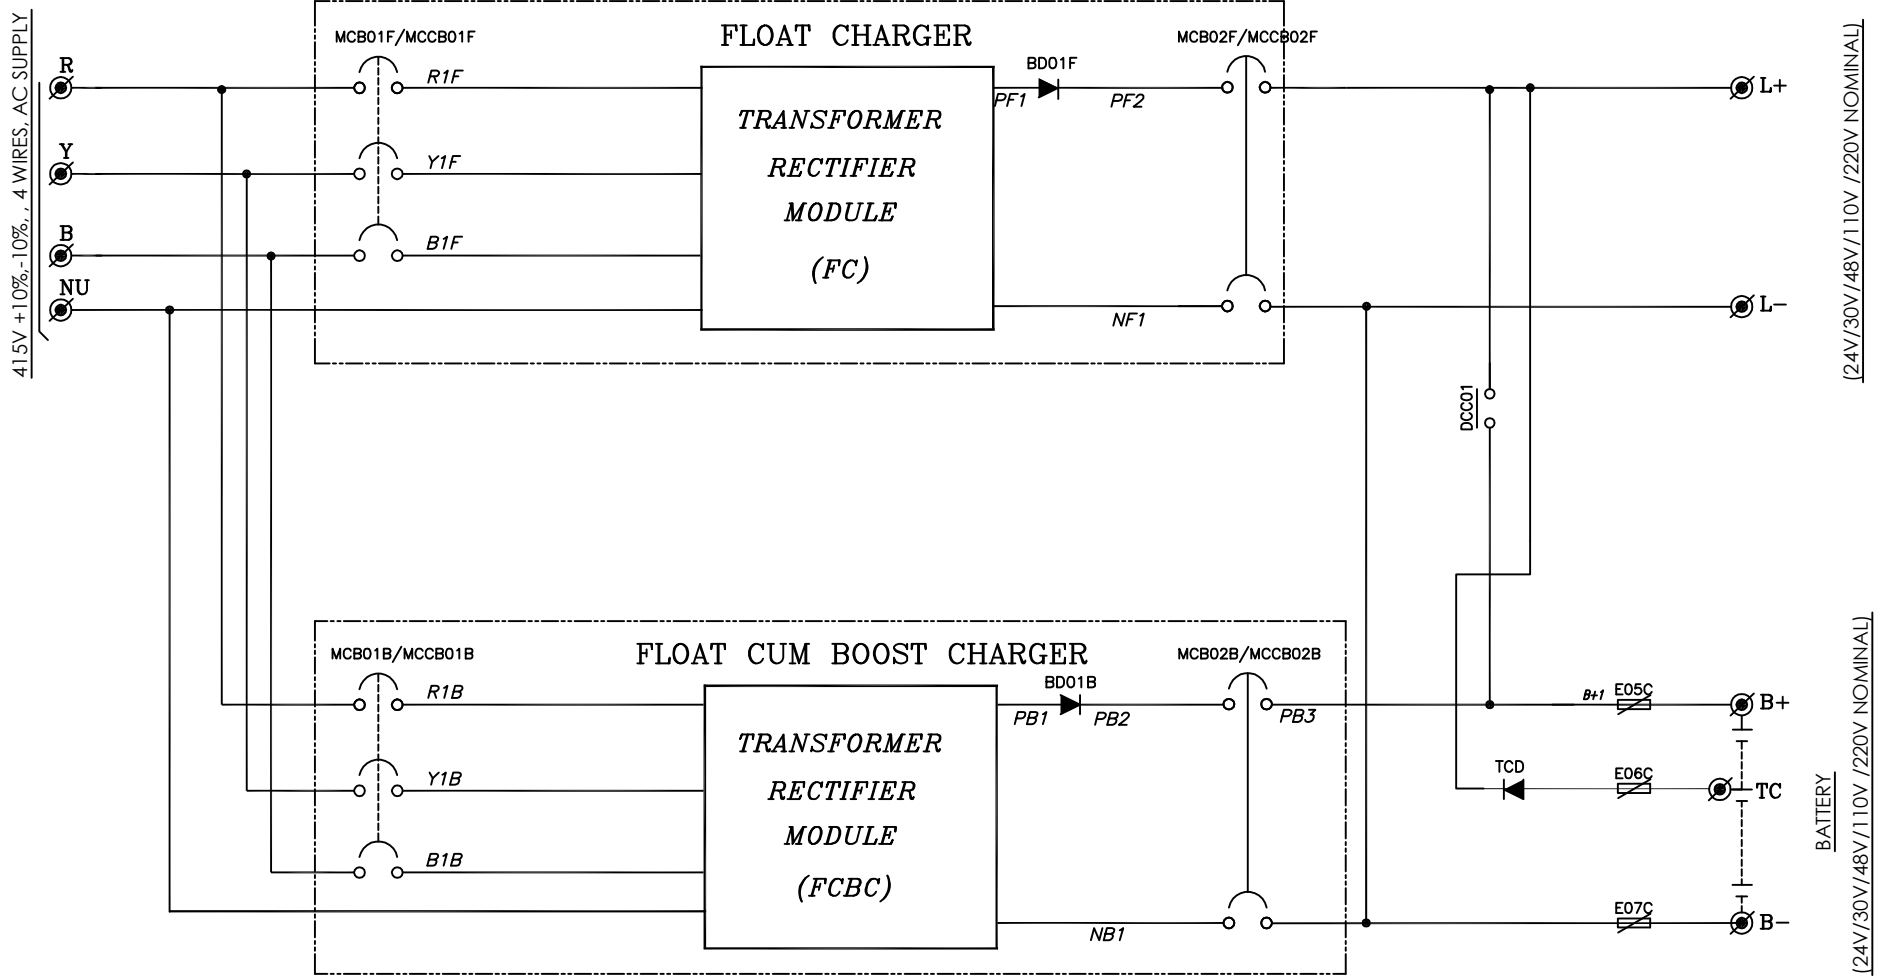

THIS IS TENTATIVE SLD.  
IT CAN BE CHANGED AS PER CUSTOMER REEQUIREMENT.

Title: - SINGLE LINE DIAGRAM OF FLOAT CHARGER & FLOAT CUM BOOST CHARGER AS PER ATTACHED TECH SPEC.

LIVELINE ELECTRONICS  
10th Ramchandrapur, Narendrapur,  
Kolkata-700 103  
telephone: 033-64520115  
-mail: info@livelineindia.com  
www.livelineindia.com



DATE	Issue	Date	Name
Dm.	S.DAS	21.08.18	
Chd.	S.GIRI		
App			

Client :

Drg.No : SLD-FC&FCB-1-18BCH, REV 00

SCALE : NTS  
PROJ.REF :  
SHEET NO : 01  
NO.OF SHEET :01

'F' STANDS FOR THE COMPONENTS OF FLOAT CHARGER  
'B' STANDS FOR THE COMPONENTS OF FLOAT CUM BOOST CHARGER  
AND 'C' STANDS FOR COMMON ITEMS

THIS DRAWING AND DESIGN IS UNLIMITED  
LIVELINE ELECTRONICS AND MUST NOT BE  
COPIED OR LENT WITHOUT THERE PERMISSION  
IN WRITING